


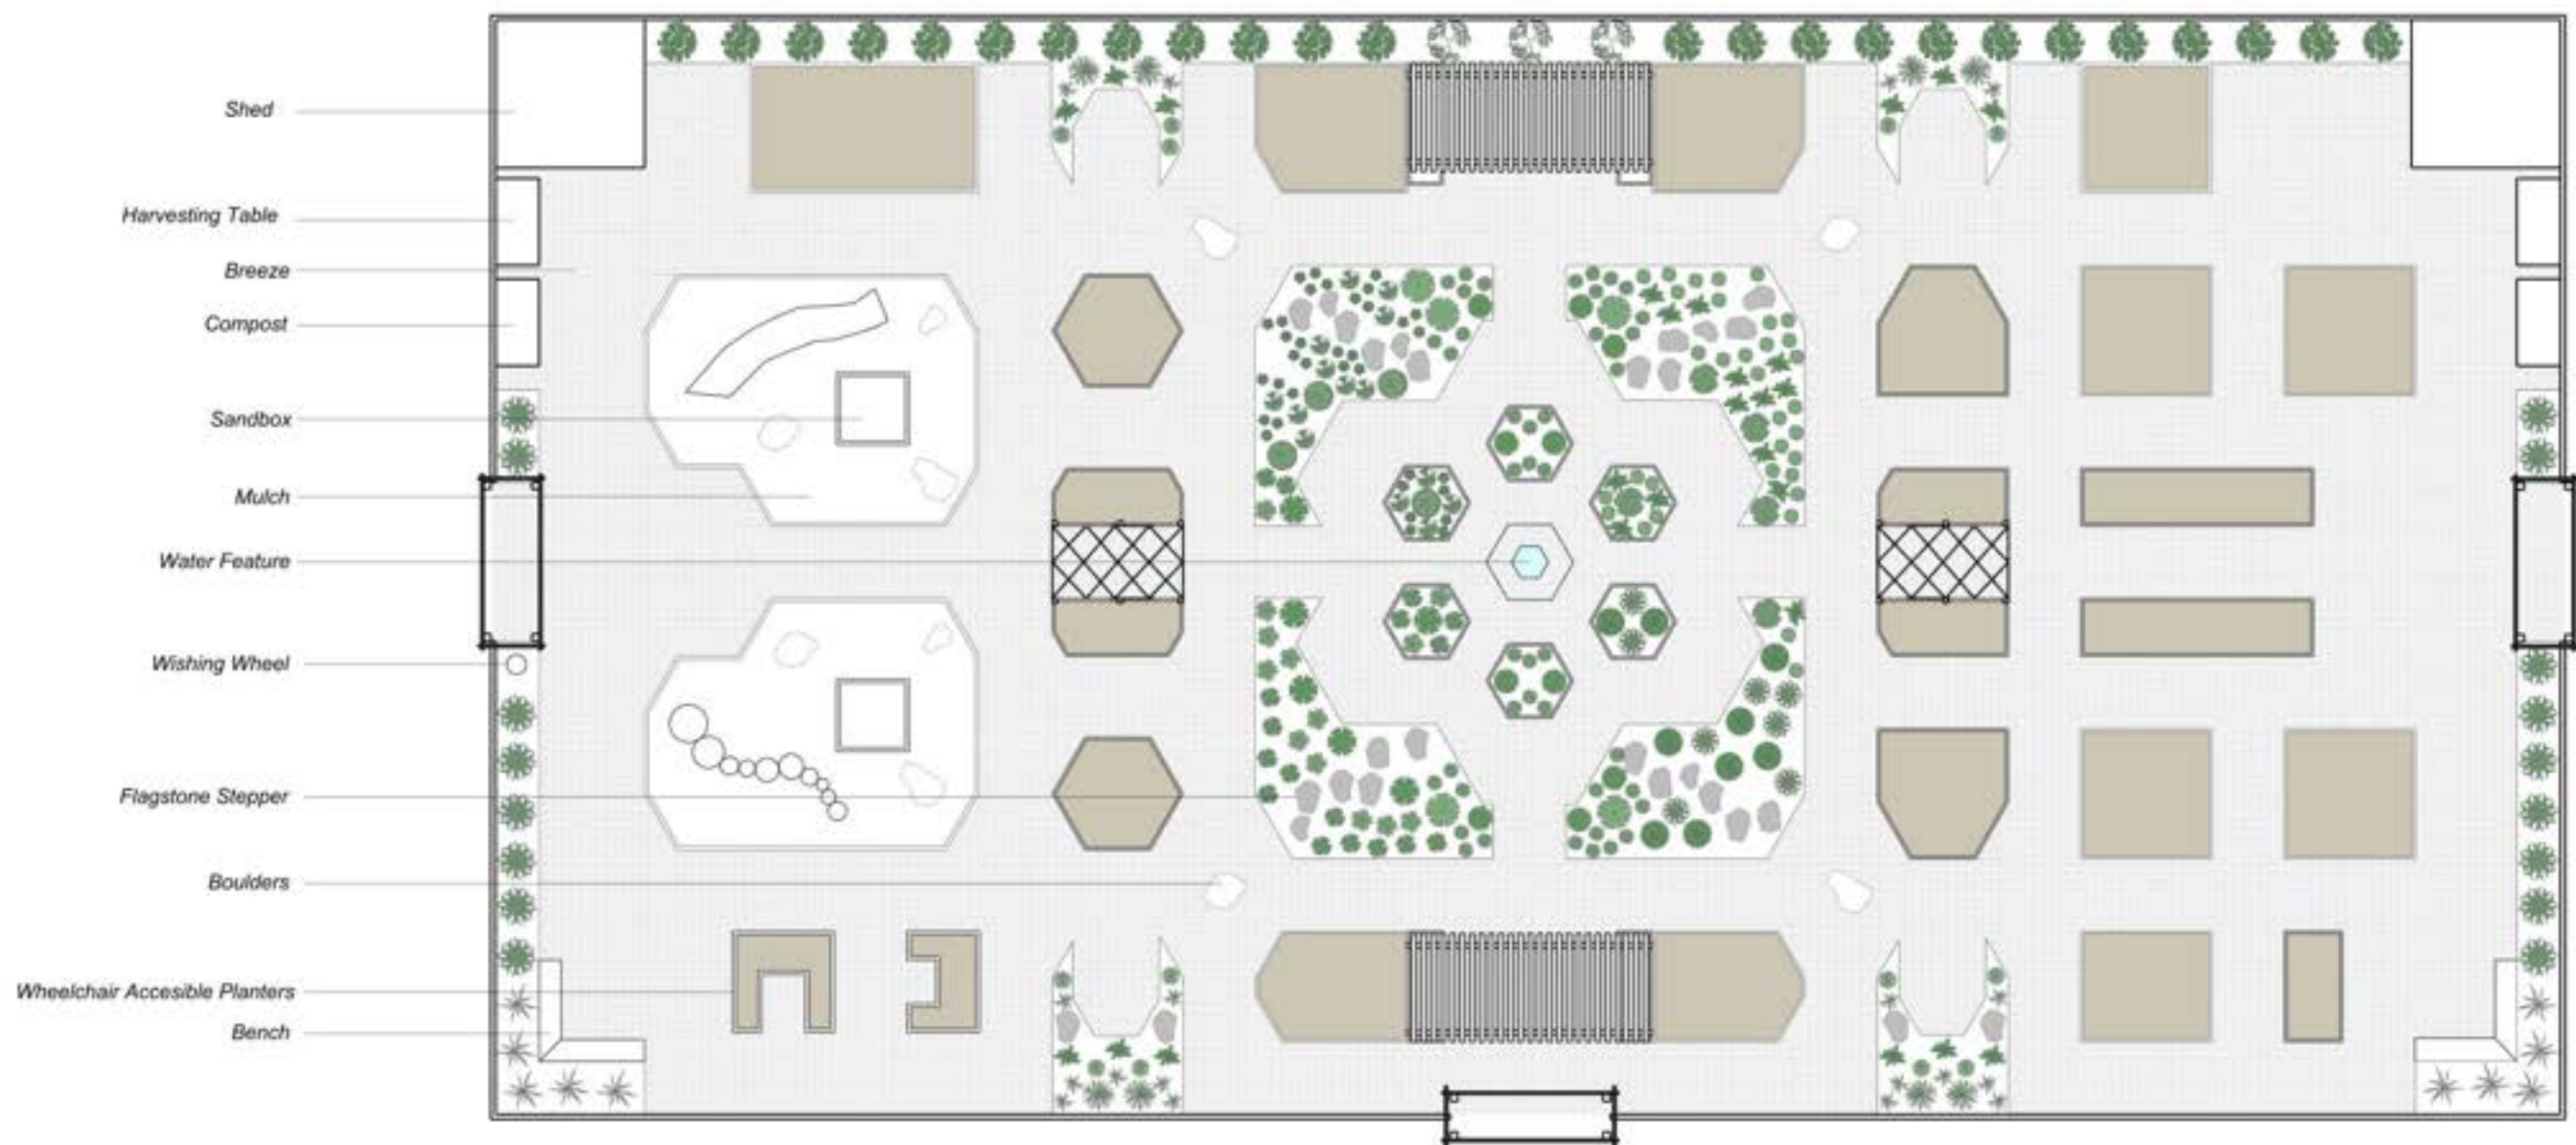

- | | | | |
|--|--|---|--|
| ● Golden Currant, <i>Ribes aureum</i> (4) | ● Agastache Sunset Hyssop, <i>Agastache rupestris</i> (10) | ★ Marigold, <i>Tagetes</i> (44) | ● Hyssop, <i>Hyssopus officinalis</i> (16) |
| ● Garden Strawberry, <i>Fragaria x ananassa</i> (35) | ● Chocolate Flower, <i>Berlandiera lyrata</i> (55) | ● Yarrow, <i>Achillea millefolium</i> (16) | ● Althea Rose of Sharon Lavender Chiffon (3) |
| ● Stevia, <i>Stevia rebaudiana</i> (14) | ● Rosemary, <i>Salvia rosmarinus</i> (5) | ★ Feathered Reed Grass, <i>Calamagrostis acutiflora</i> (10) | |
| ● Lamb's Ear, <i>Stachys byzantina</i> (18) | ● Bottle Brushes, <i>Callistemon</i> (6) | ● Service Berry Standing Ovation, <i>Amelanchier alnifolia</i> (24) | |
| ● Snap Dragon, <i>Antirrhinum majus</i> (14) | ● Hummingbird Mint, <i>Agastache cana</i> (9) | ● Maiden Grass, <i>Miscanthus sinensis</i> (24) | |
| ● Lavender, <i>Lavandula intermedia</i> (5) | ● Stone Crop, <i>Sedum</i> (35) | ● Echinacea, <i>Echinacea</i> (10) | |



SKYSCAPE GARDENS, INC.
3905 E. 2ND AVE.
DENVER, CO 80206
P 857-222-4924
www.skyscapedgardens.com

Firefly/DUG Community Garden


Set: Planting Plan
Scale: To Scale
Date: 05162023
Drawn: nb + ap

L-1



Set: Plan
Scale: To Scale
Date: 05162023
Drawn: nb + ap

L-2

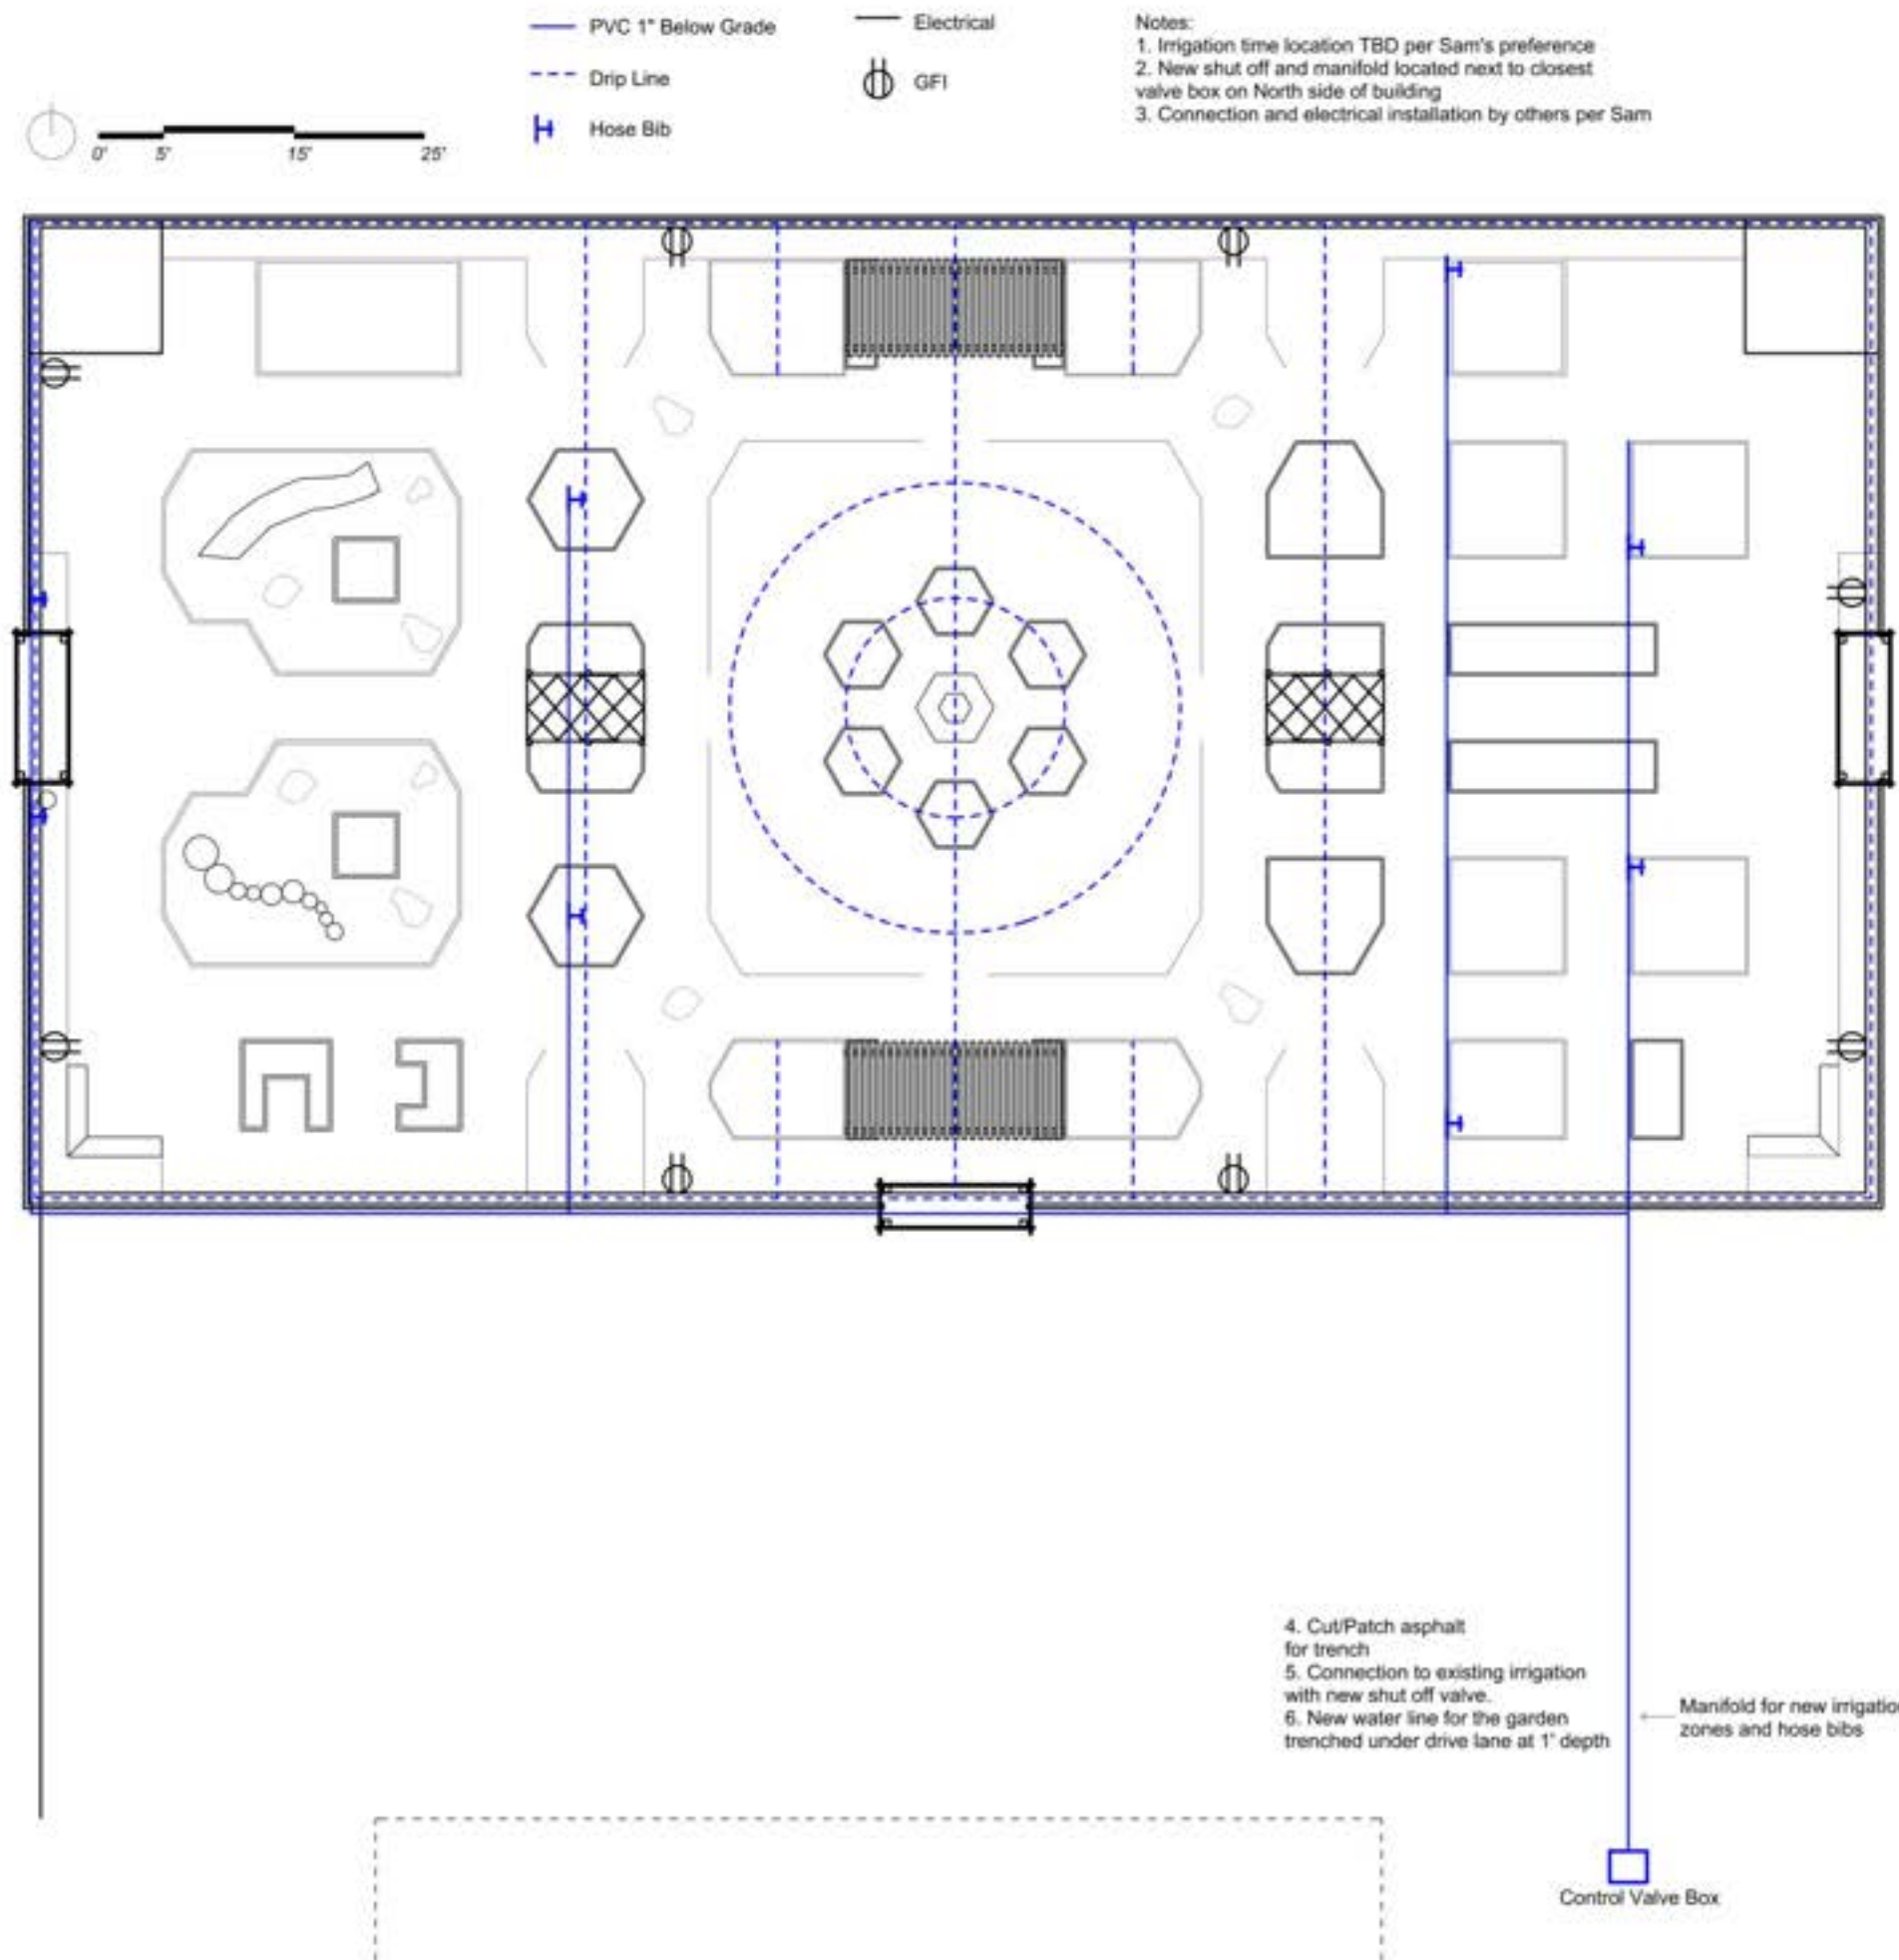

SKYSCAPE GARDENS, INC.
 2829 E. 4TH AVE.
 DENVER, CO 80206
 P 857-222-4924
www.skyscapedgardens.com


Firefly/DUG Community Garden

Set: Irrigation + Electrical Plan
 Scale: To Scale
 Date: 05162023
 Drawn: nb + ap

L-3



- Edison String Lights
- Staked Lights
- Lamps

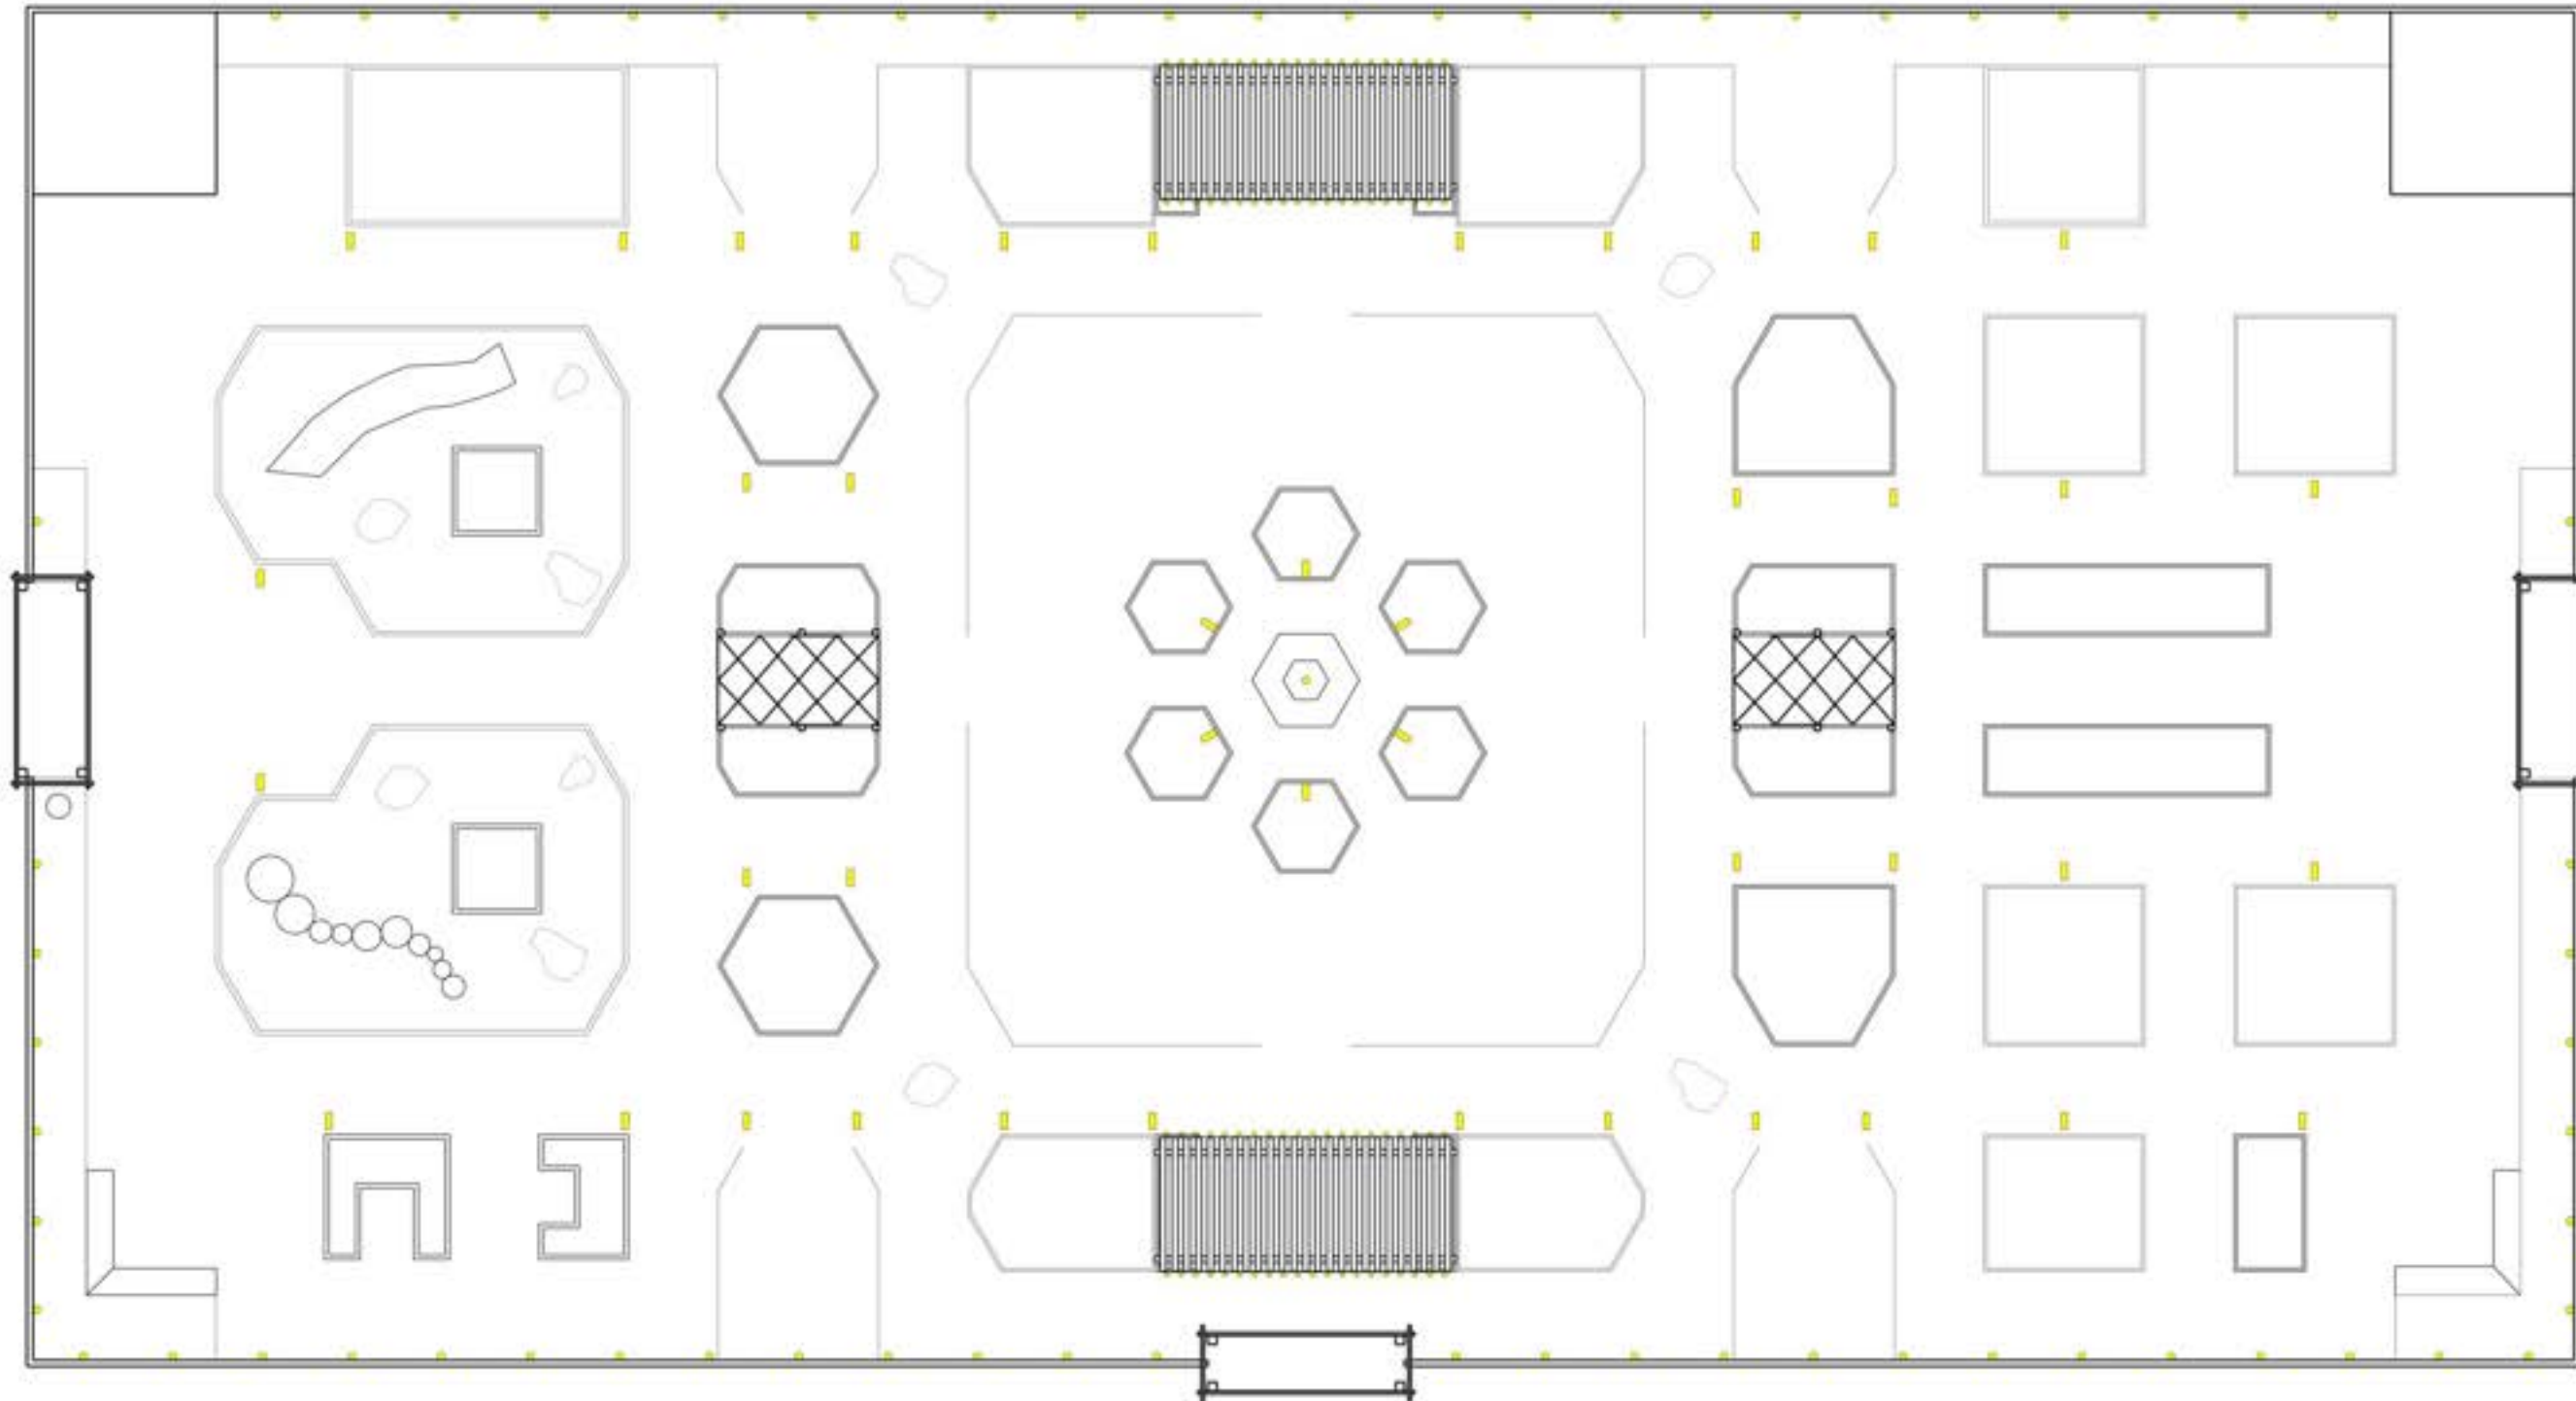


SKYSCAPE GARDENS, INC.
2829 E. 4TH AVE.
DENVER, CO 80206
P 857-222-4924
www.skyscapedesign.com

Firefly/DUG Community Garden

Set: Lighting Plan
Scale: To Scale
Date: 05162023
Drawn: nb + ap

L-4

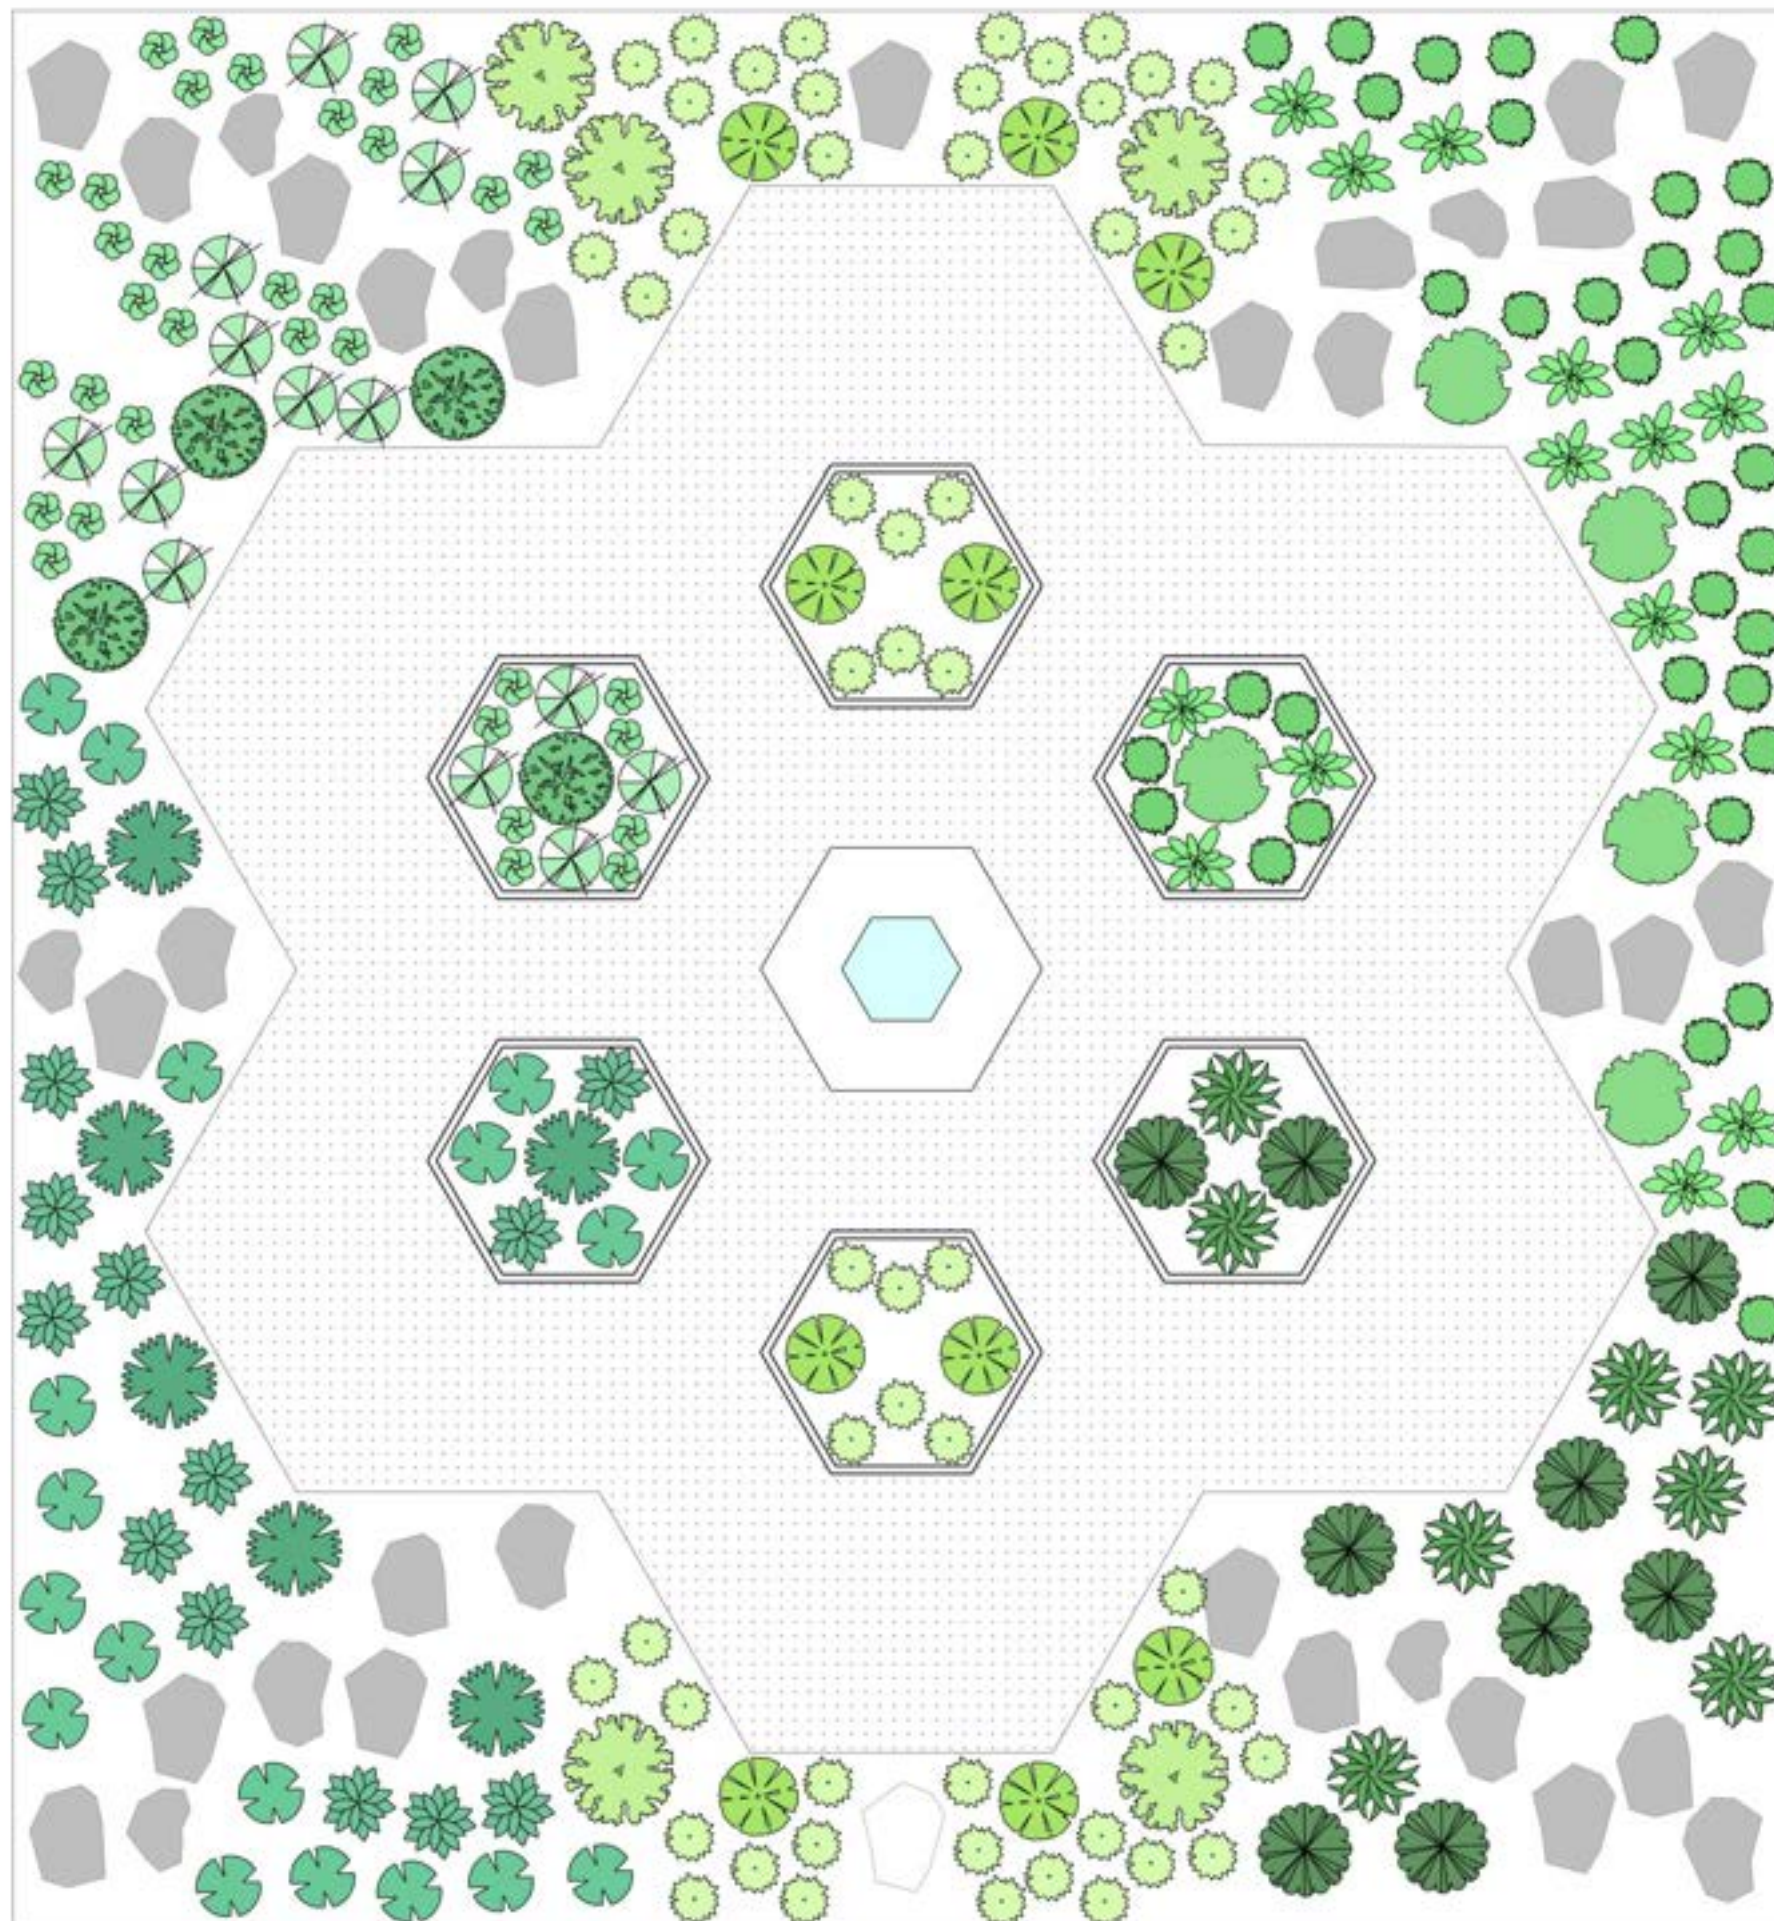

Touch

- Lamb's Ear, *Stachys byzantina* (x)
- Snap Dragon
- Bottle Brushes

Taste

- Golden Currant, *Ribes aureum* (x)
- Garden Strawberry, *Fragaria x ananassa* (x)
- Stevia

Smell

- Agastache Sunset Hyssop, *Agastache rupestris* (x)
- Chocolate Flower, *Berlandiera lyrata* (x)
- Rosemary, *Salvia rosmarinus* (x)

Sight

- Stone Crop, *Sedum* (x)
- Echinacea, *Echinacea* (x)
- Lavender, *Lavandula intermedia* (x)

Sound

- Maiden Grass, *Miscanthus sinensis* (x)
- Hummingbird Mint



SKYSCAPE GARDENS, INC.

3905 E. 2ND AVE.
DENVER, CO 80206
P 857-222-4924

www.skyscapedgardens.com

Firefly/DUG Community Garden

Set: Sensory Garden
Scale: Not To Scale
Date: 04282023
Drawn: nb + ap

L-5



SKYSCAPE GARDENS, INC.

3905 E. 2ND AVE.
DENVER, CO 80206
P 857-222-4924
www.skyscapedgardens.com

**Firefly/DUG
Community Garden**

Set: Gateway feature
Scale: To Scale
Date: 04282023
Drawn: nb + ap

L-6



SKYSCAPE GARDENS, INC.

3905 E. 2ND AVE.
DENVER, CO 80206
P 857-222-4924
www.skyscapedgardens.com



**Firefly/DUG
Community Garden**

Set: Gathering space
Scale: Not To Scale
Date: 04282023
Drawn:nb + ap

L-7



SKYSCAPE GARDENS, INC.
2829 E. 4TH AVE.
DENVER, CO 80206
P 857-222-4924
www.skyscapedgardens.com



**Firefly/DUG
Community Garden**

Set: Sanctuary space
Scale: To Scale
Date: 04282023
Drawn: nb + ap

L-8



SKYSCAPE GARDENS, INC.
2829 E. 4TH AVE.
DENVER, CO 80206
P 857-222-4924
www.skyscapedgardens.com



**Firefly/DUG
Community Garden**

Set: Learning & playspace
Scale: Not To Scale
Date: 04282023
Drawn: nb + ap

L-9



SKYSCAPE GARDENS, INC.
2829 E. 4TH AVE.
DENVER, CO 80206
P 857-222-4924
www.skyscapedgardens.com

**Firefly/DUG
Community Garden**
Set: Sensory garden
Scale: Not To Scale
Date: 04282023
Drawn:nb + ap
L-10



SKYSCAPE GARDENS, INC.
2829 E. 4TH AVE.
DENVER, CO 80206
P 857-222-4924
www.skyscapedgardens.com



**Firefly/DUG
Community Garden**
Set: Breezeway feature
Scale: Not To Scale
Date: 04282023
Drawn:nb + ap

L-11



SKYSCAPE GARDENS, INC.
2829 E. 4TH AVE.
DENVER, CO 80206
P 857-222-4924
www.skyscapedgardens.com



**Firefly/DUG
Community Garden**
Set: Sensory Garden
Scale: Not To Scale
Date: 04282023
Drawn:nb + ap

L-12



SKYSCAPE GARDENS, INC.
2829 E. 4TH AVE.
DENVER, CO 80206
P 857-222-4924
www.skyscapedgardens.com



Firefly/DUG
Community Garden
Set: Storage/Cubby space
Scale: Not To Scale
Date: 04282023
Drawn:nb + ap

L-13



SKYSCAPE GARDENS, INC.
2829 E. 4TH AVE.
DENVER, CO 80206
P 857-222-4924
www.skyscapedgardens.com

Firefly/DUG
Community Garden
Set: Image Board
Scale: Not To Scale
Date: 04282023
Drawn:nb + ap

L-14



SKYSCAPE GARDENS, INC.
2829 E. 4TH AVE.
DENVER, CO 80206
P 857-222-4924
www.skyscapedgardens.com

Firefly/DUG
Community Garden
Set: Image Board
Scale: Not To Scale
Date: 04282023
Drawn:nb + ap

L-15



1



2



3



4



5



6



7



8



9

1. Agastache Sunset Hyssop
2. Garden Strawberries
3. Lamb's Ear
4. Lavender
5. Bottle Brush
6. Feathered Reed Grass
7. Hummingbird Mint
8. Chocolate Flower
9. Golden Currant



SKYSCAPE GARDENS, INC.
2829 E. 4TH AVE.
DENVER, CO 80206
P 857-222-4924
www.skyscapedgardens.com

Firefly/DUG Community Garden

Set: Image Board
Scale: Not To Scale
Date: 04282023
Drawn:nb + ap


L-16



- 11. Althea Rose of Sharon
- 12. Marigold
- 13. Snap Dragon
- 14. Rosemary
- 15. Stone Crop
- 16. Service Berry Standing Ovation
- 17. Yarrow
- 18. Stevia



SKYSCAPE GARDENS, INC.
 2829 E. 4TH AVE.
 DENVER, CO 80206
 P 857-222-4924
www.skyscapedgardens.com

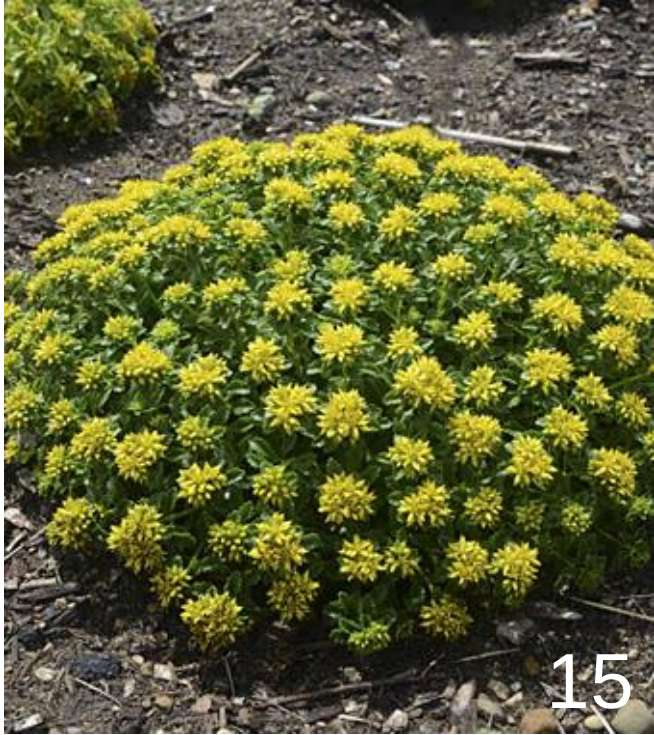

Firefly/DUG
Community Garden
 Set: Image Board
 Scale: Not To Scale
 Date: 04282023
 Drawn:nb + ap
L-17



19



20



21

- 19. Kinetic Wind Sculpture
- 20. Fairy Sculpture
- 21. Fountain
- 22. Wind Chime
- 23. Spinning Compost Bin



SKYSCAPE GARDENS, INC.
2829 E. 4TH AVE.
DENVER, CO 80206
P 857-222-4924
www.skyscapedgardens.com



22



23

**Firefly/DUG
Community Garden**

Set: Image Board
Scale: To Scale
Date: 04282023
Drawn: nb + ap

L-18